


18701

- 10 VOLT WALL BRACKET LIGHT WITH SWITCH
- 10 VOLT RECEPTACLE
- 10 VOLT RECEPTACLE WATERPROOF
- 10 VOLT DOUBLE SWITCH
- POWER PANEL

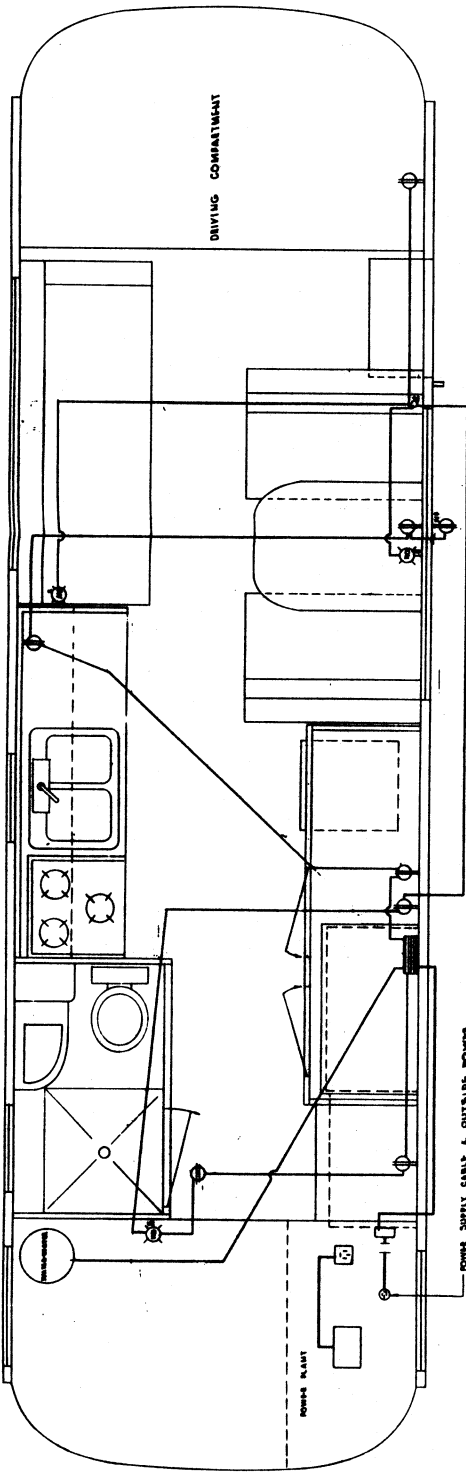


POWER SUPPLY CABLE & OUTSIDE POWER PLANT

BATTERY

TYPE	NO.	DESCRIPTION	DATE	BY
REVISION				
DATE				
<b>TRACO CORPORATION</b>				
1000 EAST 14TH AVENUE, DENVER, COLORADO 80202				
A DIVISION OF TRACO ELECTRIC COMPANY, INC.				
PROJECT: <b>18701</b>				
DRAWING NO: <b>18701-56</b>				
SCALE: <b>AS SHOWN</b>				
DRAWN BY: <b>W. J. HARRIS</b>				
CHECKED BY: <b>W. J. HARRIS</b>				
DATE: <b>10/17/56</b>				

18702

- 12 VOLT CHILING LIGHT
- 12 VOLT WALL LIGHT
- 12 VOLT LIGHT SWITCH

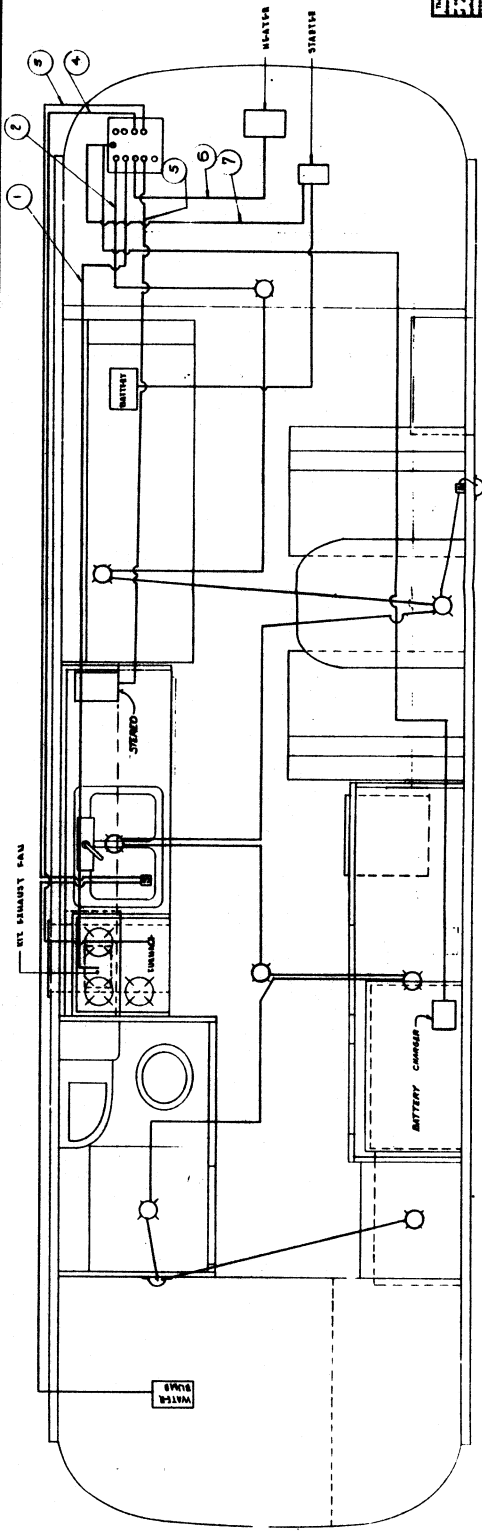

12 VOLT CHILING LIGHT

BATTERY

BATTERY CHARGER

HEATER

STARTER RELAY SWITCH

TYPE	NO.	DESCRIPTION	DATE	BY
REVISION				
DATE				
<b>TRACO CORPORATION</b>				
1000 EAST 14TH AVENUE, DENVER, COLORADO 80202				
A DIVISION OF TRACO ELECTRIC COMPANY, INC.				
PROJECT: <b>18702</b>				
DRAWING NO: <b>18702-56</b>				
SCALE: <b>AS SHOWN</b>				
DRAWN BY: <b>W. J. HARRIS</b>				
CHECKED BY: <b>W. J. HARRIS</b>				
DATE: <b>10/17/56</b>				